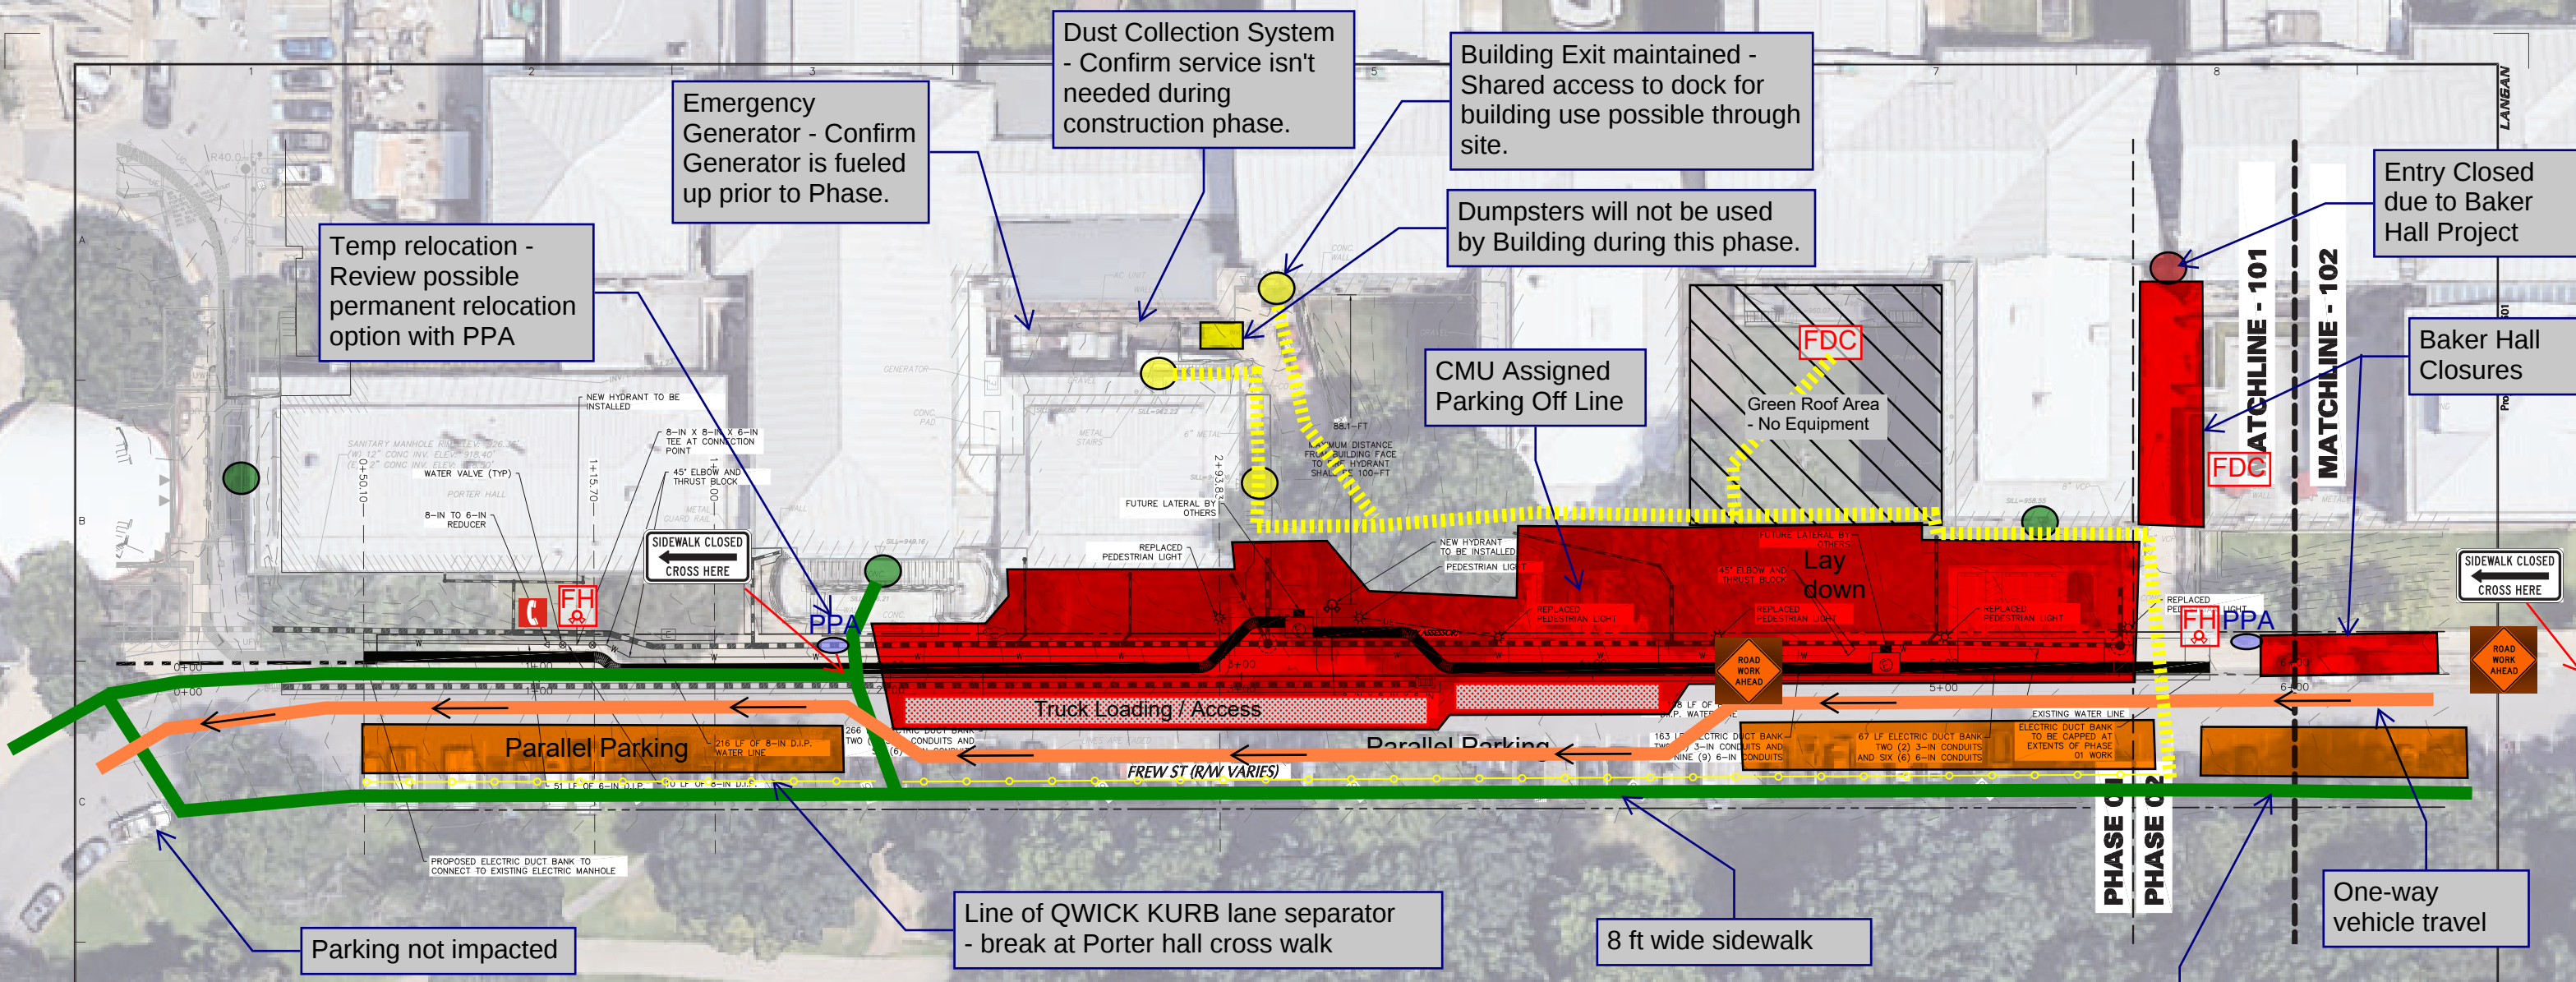


LEGEND

- Emergency Call Box
- Fire Department Connection
- Fire Hydrant
- Pittsburgh Parking Authority - Pay Station
- Qwick Kurb Lane Separator
- Building Access - Temp Impact
- Building Access - No Impact
- Pedestrian Travel
- Public Vehicle Travel

Phase 1B

LANGAN Langan Engineering and Environmental Services, Inc. 2400 Ansys Drive, Suite 403 Canonsburg, PA 15317 T: 724.514.5100 F: 724.514.5101 www.langan.com			Project CMU – FREW STREET UTILITY CORRIDOR ALLEGHENY COUNTY PENNSYLVANIA		Drawing Title UTILITY PLAN AND PROFILE VIEW PHASE 01		Project No. 250164501		Drawing No. CU101.1	
Date: 12/14/2022 Time: 13:03 User: adjacobs Style Table: Langan.sbt Layout: CU101.1 Document Code: 250164501-0501-CU101-0101			Date NOVEMBER 10, 2022		Date NOVEMBER 10, 2022		Date NOVEMBER 10, 2022		Date NOVEMBER 10, 2022	
Revisions			Signature		Signature		Signature		Signature	
Revisions			Signature		Signature		Signature		Signature	

Pedestrian Travel

Emergency Generator

Dust Collection System

Dumpsters

Stop conduits within fence line.

Entry Closed due to Baker Hall Project

Baker Hall Closures

SIDEWALK CLOSED
CROSS HERE

SIDEWALK CLOSED
CROSS HERE

ROAD WORK AHEAD

Parallel Parking

Parallel Parking

Truck Loading / Access

Line of QWICK KURB lane separator
- break at Porter hall cross walk

CMU Assigned Parking Off Line

One-way vehicle travel

One-way vehicle travel

Parking not impacted

8 ft wide sidewalk

Pedestrian Travel

LEGEND

-  Emergency Call Box
-  Fire Department Connection
-  Fire Hydrant
-  Pittsburgh Parking Authority - Pay Station
-  Qwick Kurb Lane Separator
-  Building Access - Temp Impact
-  Building Access - No Impact
-  Pedestrian Travel
-  Public Vehicle Travel

Phase 1C